



DRAFT PROPOSED SITE PLAN

HUNT PLACE

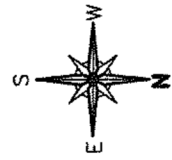

FRITH STREET

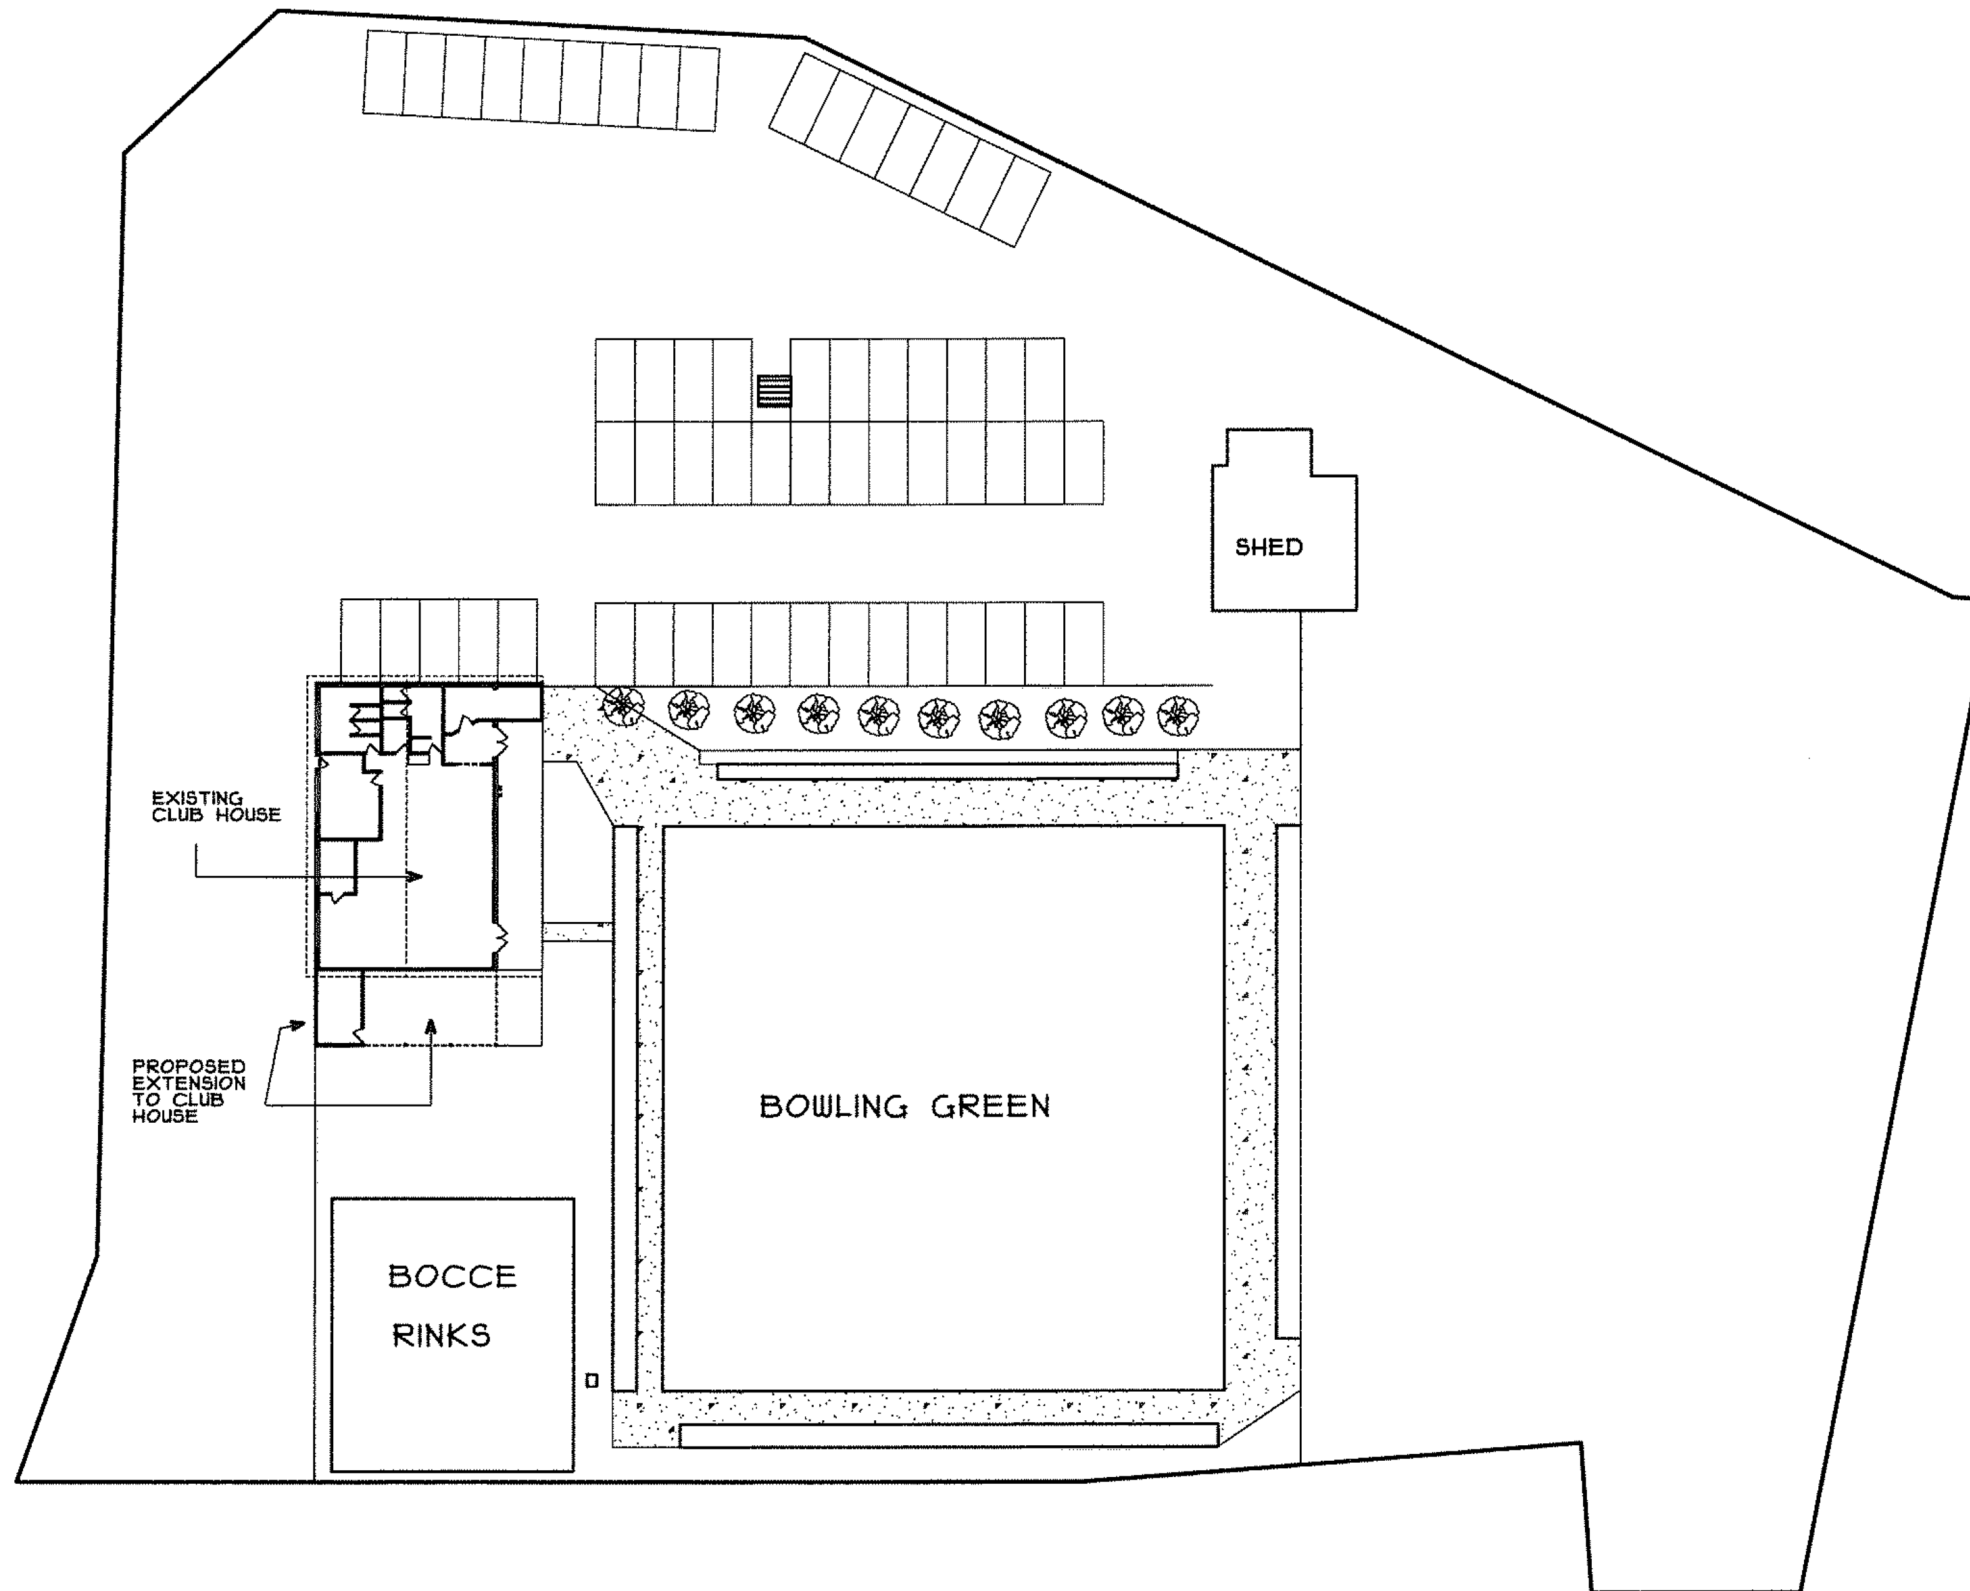


AMENDMENTS

NO.	DESCRIPTION

DATE: _____ OWNERS SIGNATURE(S): _____
 BUILDERS SIGNATURE: _____

BY	DWG No	DWG TITLE
	1	SITE PLAN
	2A	FLOOR PLAN
	3A	ELECTRICAL PLAN
	4A	ELEVATIONS
	5X	SECTION X
	7A	ROOF PLAN
	8A	SLAB SETOUT PLAN

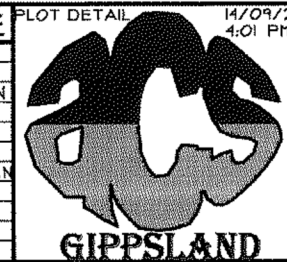

PLOT DETAIL		14/09/2017		4:01 PM		JOB NO.	
PROPOSED EXTENSION FOR							
CNR HUNT PLACE & FRITH ST							
WURRUK . 3850							
DATE	SCALE	DRAWN	DWG No	PAGES	IN SET		
4/8/2017	1:500	MHH	1	1	7		