




212 W.12th STREET

CURB CUT

CURB CUT

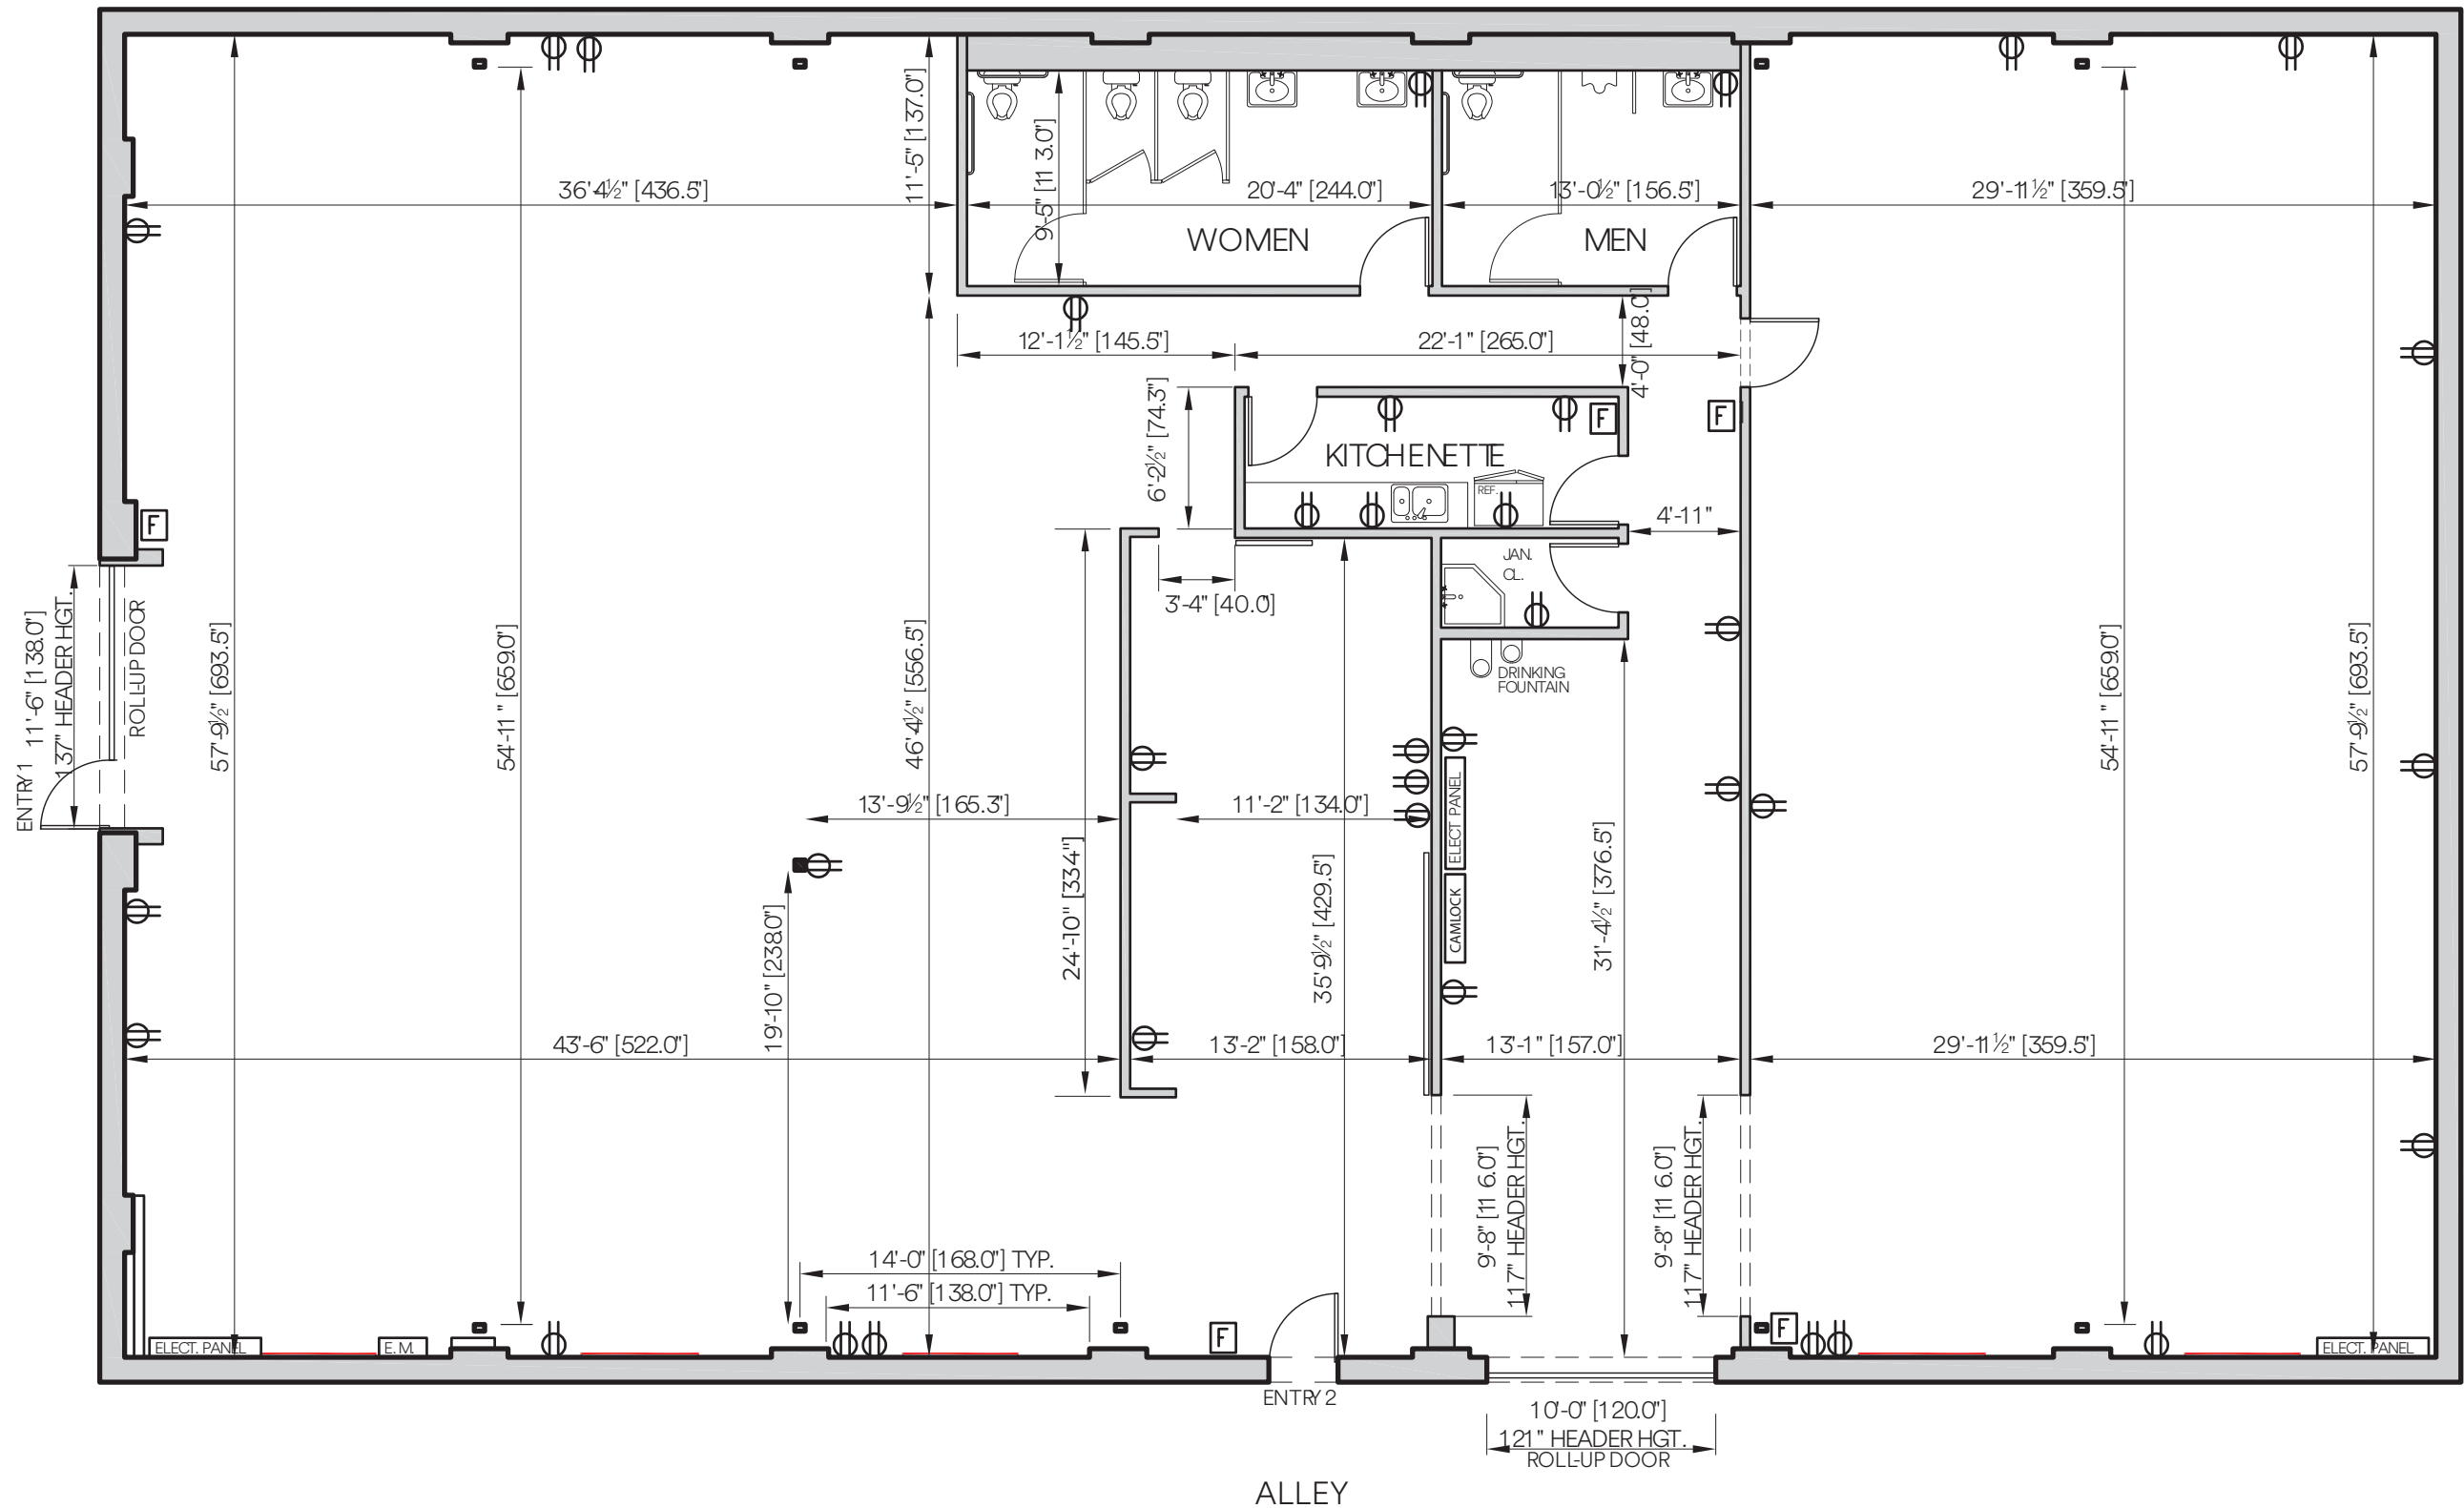

LEGEND:

-  POWER OUTLET 18" ABOVE FLOOR
-  FIRE EXTINGUISHER

FLOORPLAN
SCALE 1/8" = 1'-0"


Honeypot

212 W. 12th STREET




CURB CUT

CURB CUT

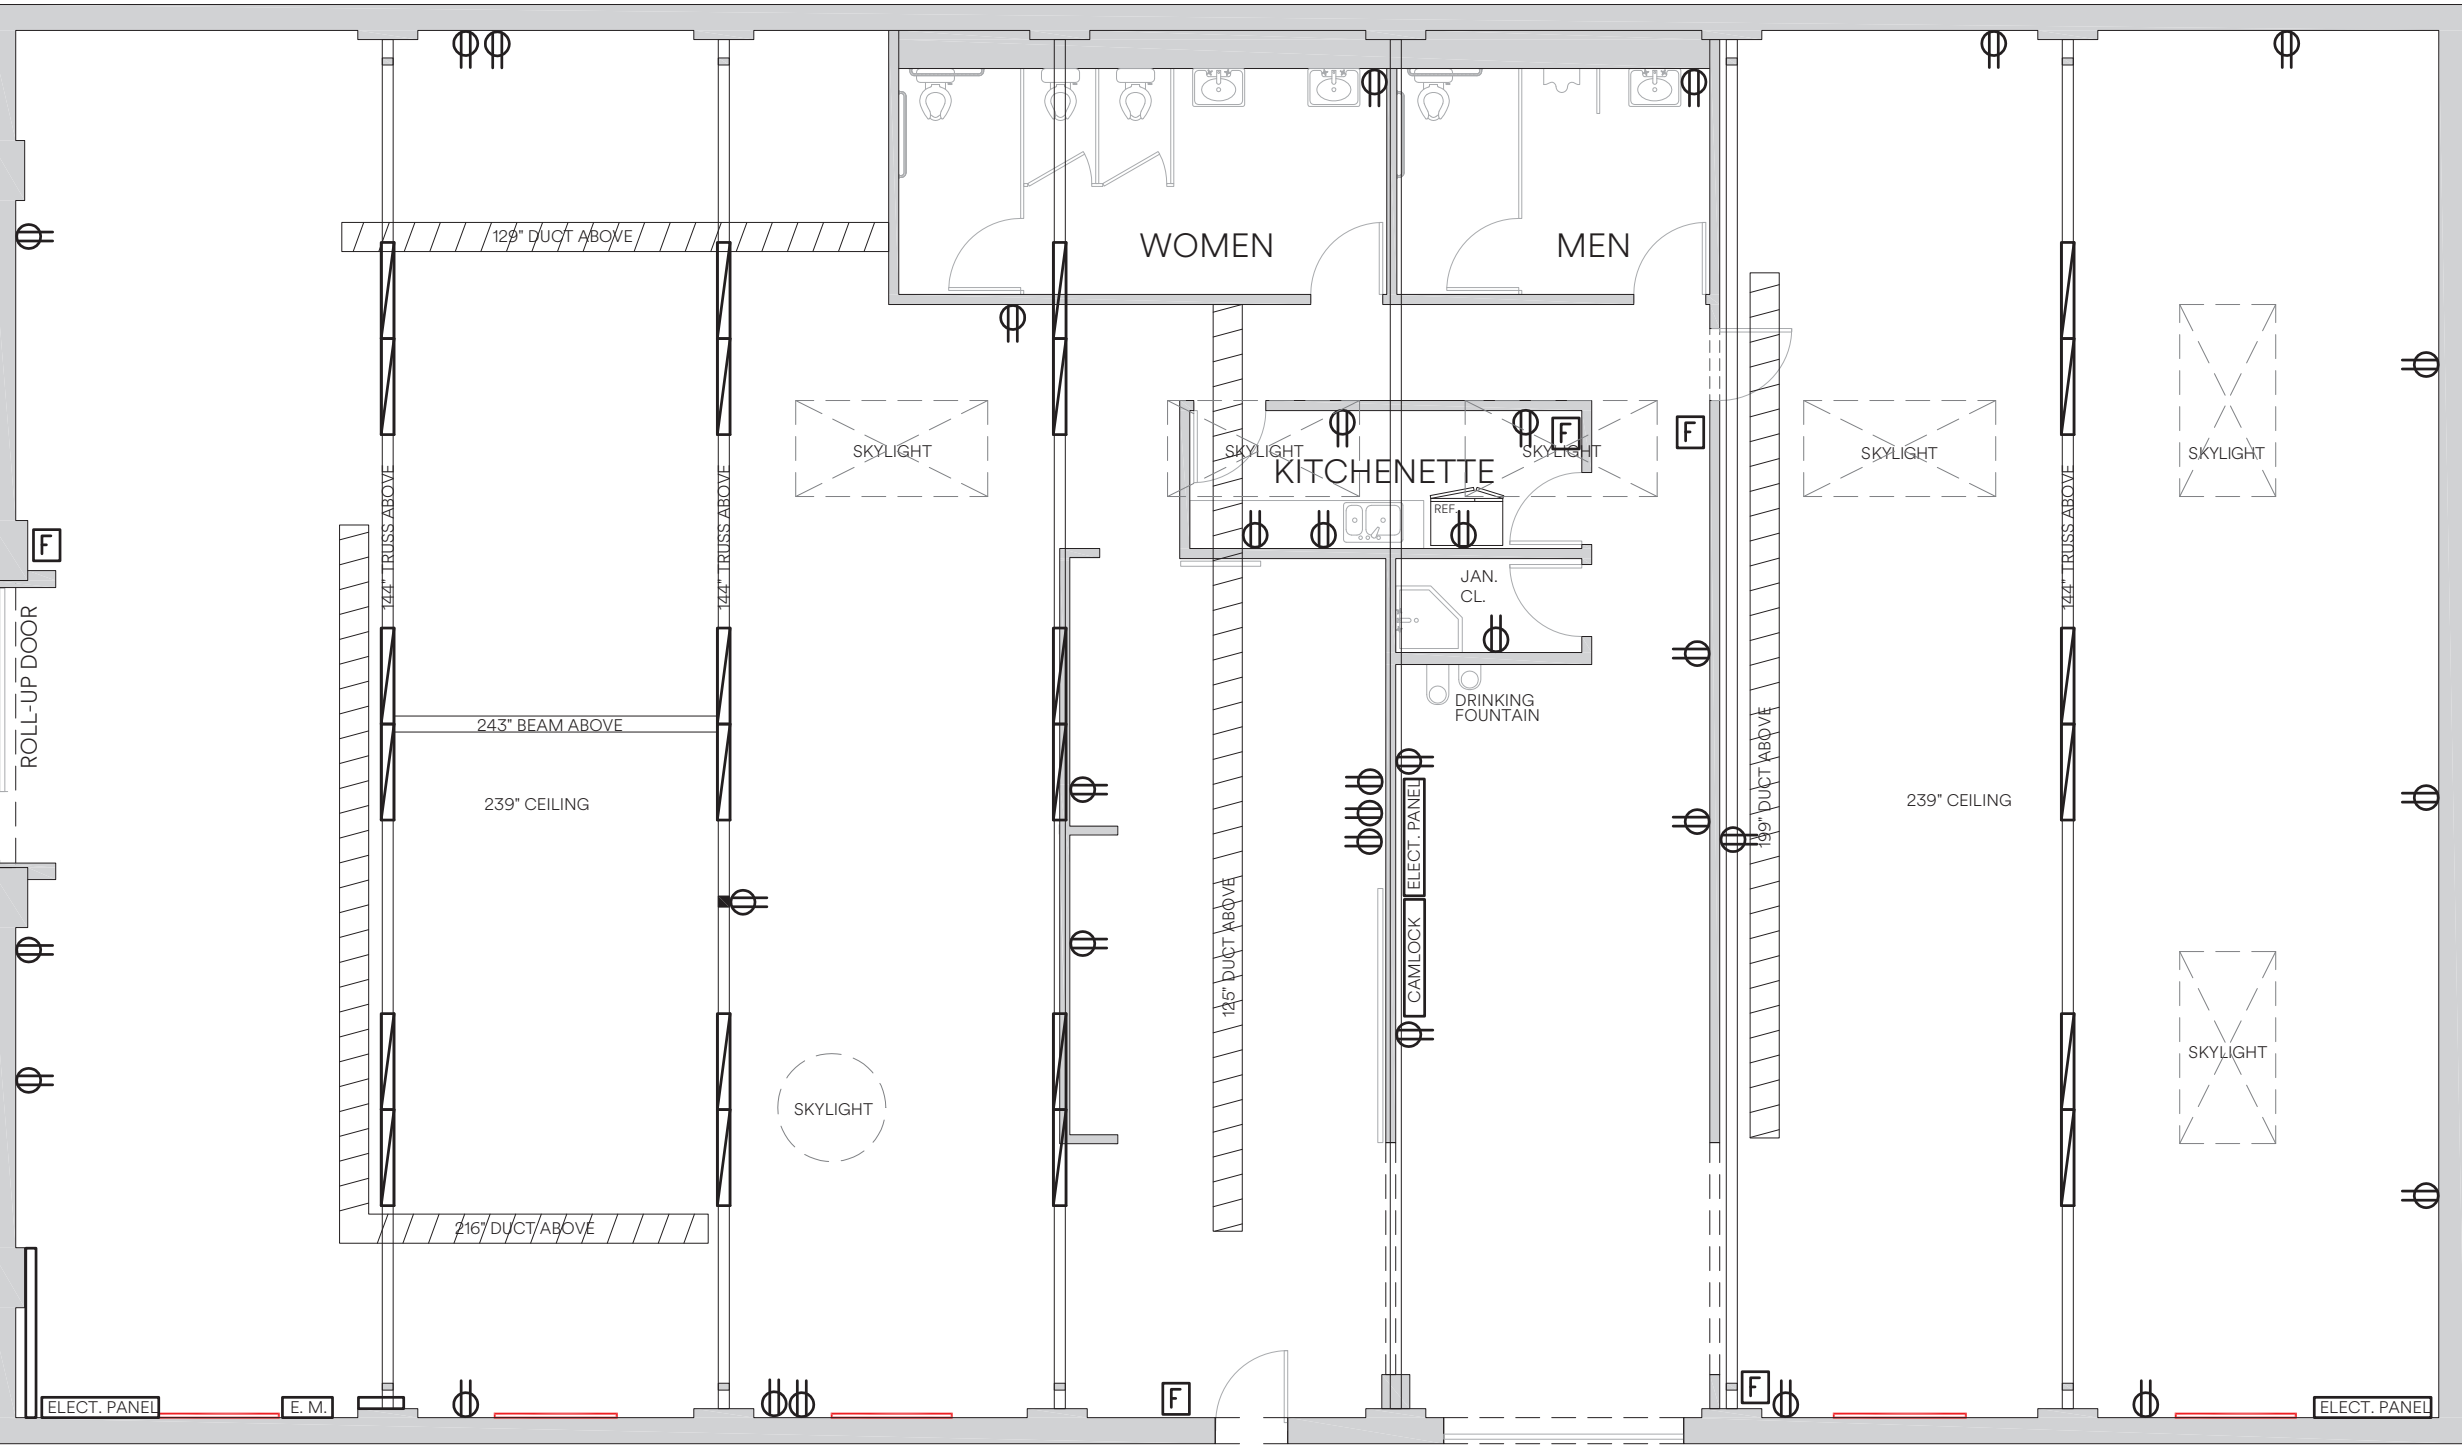ENTRY 1



LEGEND:

-  POWER OUTLET 18" ABOVE FLOOR
-  FIRE EXTINGUISHER
-  TRACK LIGHTING 12' [144"] ABOVE FLOOR

REFLECTED CEILING PLAN

SCALE 1/8" = 1'-0"

Honeypot